

All dimension to be verified on site before producing shop drawings or commencing any work. Do not scale. The copyright of this drawing remains with Warren and Mahoney Architects Ltd.


Revisions

A 03/04/2018 CONCEPT DESIGN

Notes

—

ORIGINAL DRAWING IN COLOUR

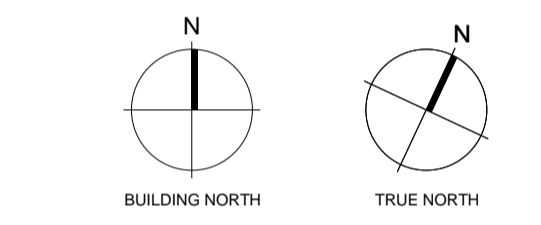

Consultants

Calibre Consulting Ltd
Project Manager
Aecom
Structural Engineer
Mechanical Engineer
Olsson Fire & Risk
Fire Engineer
Electrical Engineer
Client
MINISTRY OF HEALTH

Warren and Mahoney Architects Ltd

254 Montreal Street
PO Box 25086
Christchurch 8011
New Zealand
Phone + 64 3 961 5926

Registered Architects and Designers
www.warrenandmahoney.com


Project Title
7778 MOH BULLER
INTEGRATEDHEALTH
PAKINGTON STREET, BULLER.

Drawing Title
PACKINGTON
STREET SITE PLAN
WITH HELIPAD
(OPTION 5)

Drawing Status
WORK IN PROGRESS

Drawing Details
Scale 1 : 500 @ A1
Date 03/04/2018
Job No 7778
Drawn W&M
Checked W&M

Drawing No A00.004
Revision (A)

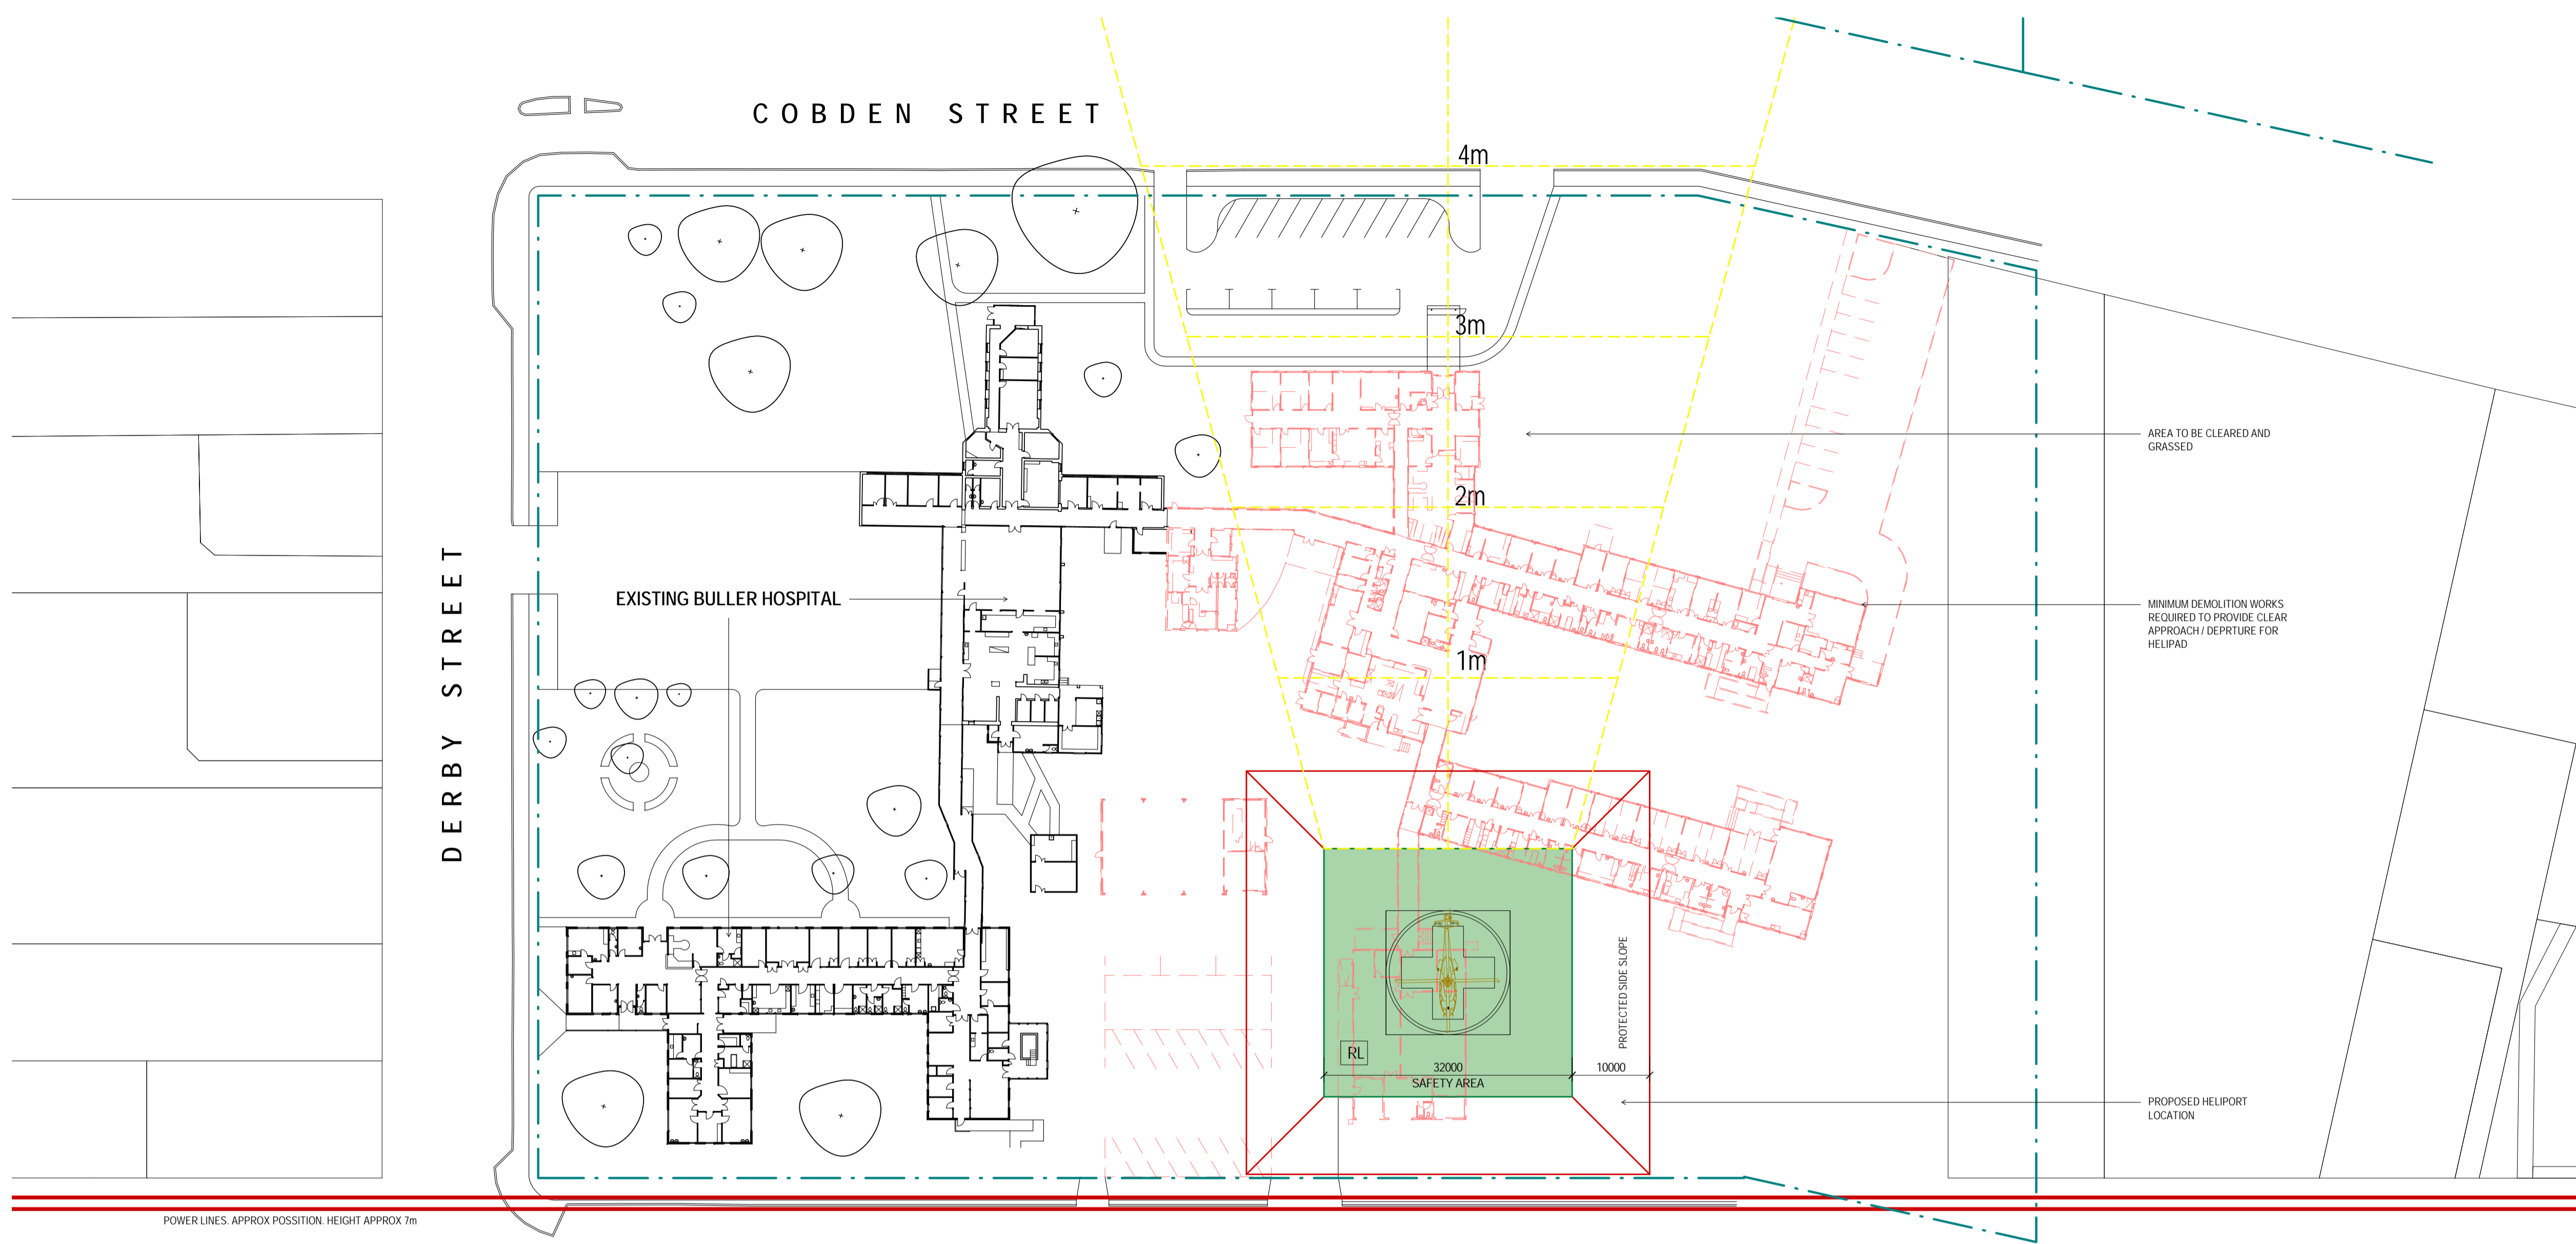

POWER LINES: APPROX POSITION. HEIGHT APPROX 7m