

All dimension to be verified on site before producing shop drawings or commencing any work. Do not scale. The copyright of this drawing remains with Warren and Mahoney Architects Ltd.

**Revisions**

A	05/05/2017	CONCEPT DESIGN
B	09/05/2017	CONCEPT DESIGN
C	20/10/2017	CONCEPT DESIGN
D	01/12/2017	CONCEPT DESIGN
E	05/12/2017	CONCEPT DESIGN
F	08/02/2018	CONCEPT DESIGN


**Notes**

—

**KEY**

- CIRCULATION
- DENTAL
- EDIPU - EMERGENCY
- EDIPU - INPATIENT
- EDIPU CORE SUPPORT
- ENGINEERING
- IFHC - EXTERNAL STORE
- IFHC - RECEPTION / WAITING
- IFHC - CORE SPACE
- IFHC - CORE SUPPORT
- IFHC - RADIOLOGY
- PATHOLOGY
- STAFF RESOURCES

ORIGINAL DRAWING IN COLOUR

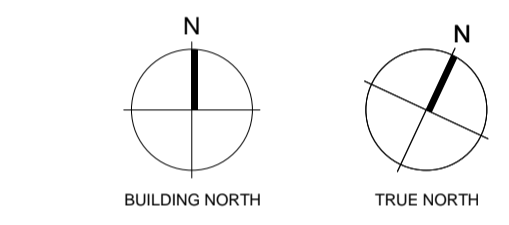

**Consultants**

- Calibre Consulting Ltd  
Project Manager
- Aecom  
Structural Engineer
- Mechanical Engineer  
Olsson Fire & Risk  
Fire Engineer
- Electrical Engineer

**Client**

MINISTRY OF HEALTH

**Warren and Mahoney Architects Ltd**

254 Montreal Street  
PO Box 25086  
Christchurch 8011  
New Zealand  
Phone + 64 3 961 5926

Registered Architects and Designers  
www.warrenandmahoney.com

**Project Title**  
**7778 MOH BULLER INTEGRATED HEALTH**  
PAKINGTON STREET, BULLER.

**Drawing Title**

**FLOOR PLAN**

**Drawing Status**

**CONCEPT DESIGN**

**Drawing Details**


Scale	1 : 100 @ A1
Date	09/02/2018
Job No	7778
Drawn	AT
Checked	JR

**Drawing No**

**A01.001**

**Revision**

**F**

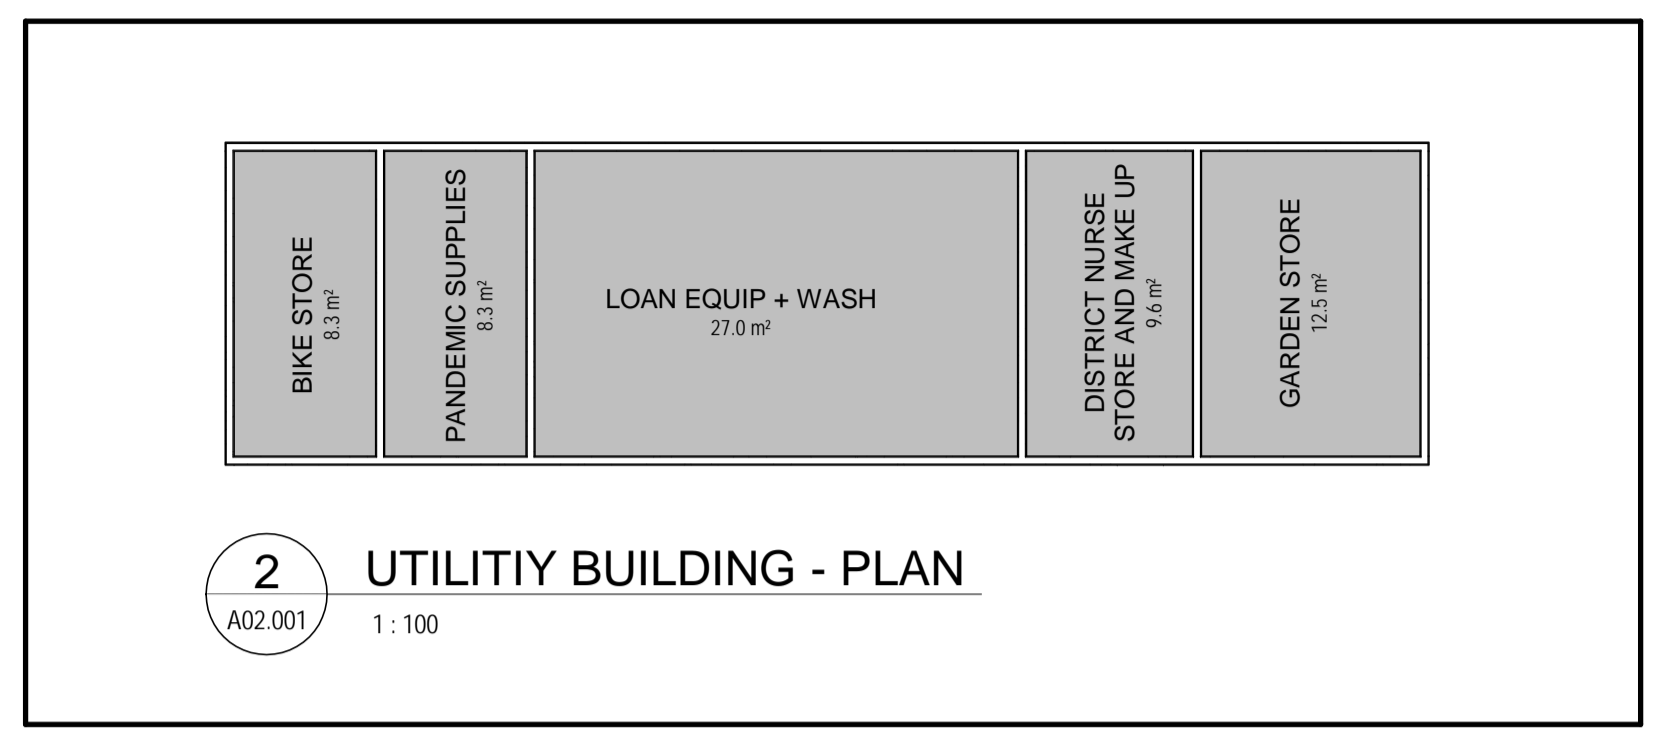

1  
2  
3  
4  
5  
6  
7  
8  
9

16726  
2338  
11017  
9473  
6164  
5317  
2551

A B C D E F G  
H J K L

4543  
6978 3281 12735 8160